


ENLARGE PLUMBING PLAN - WATER - MAIN OFFICE

SCALE 1/4"=1'-0" 2

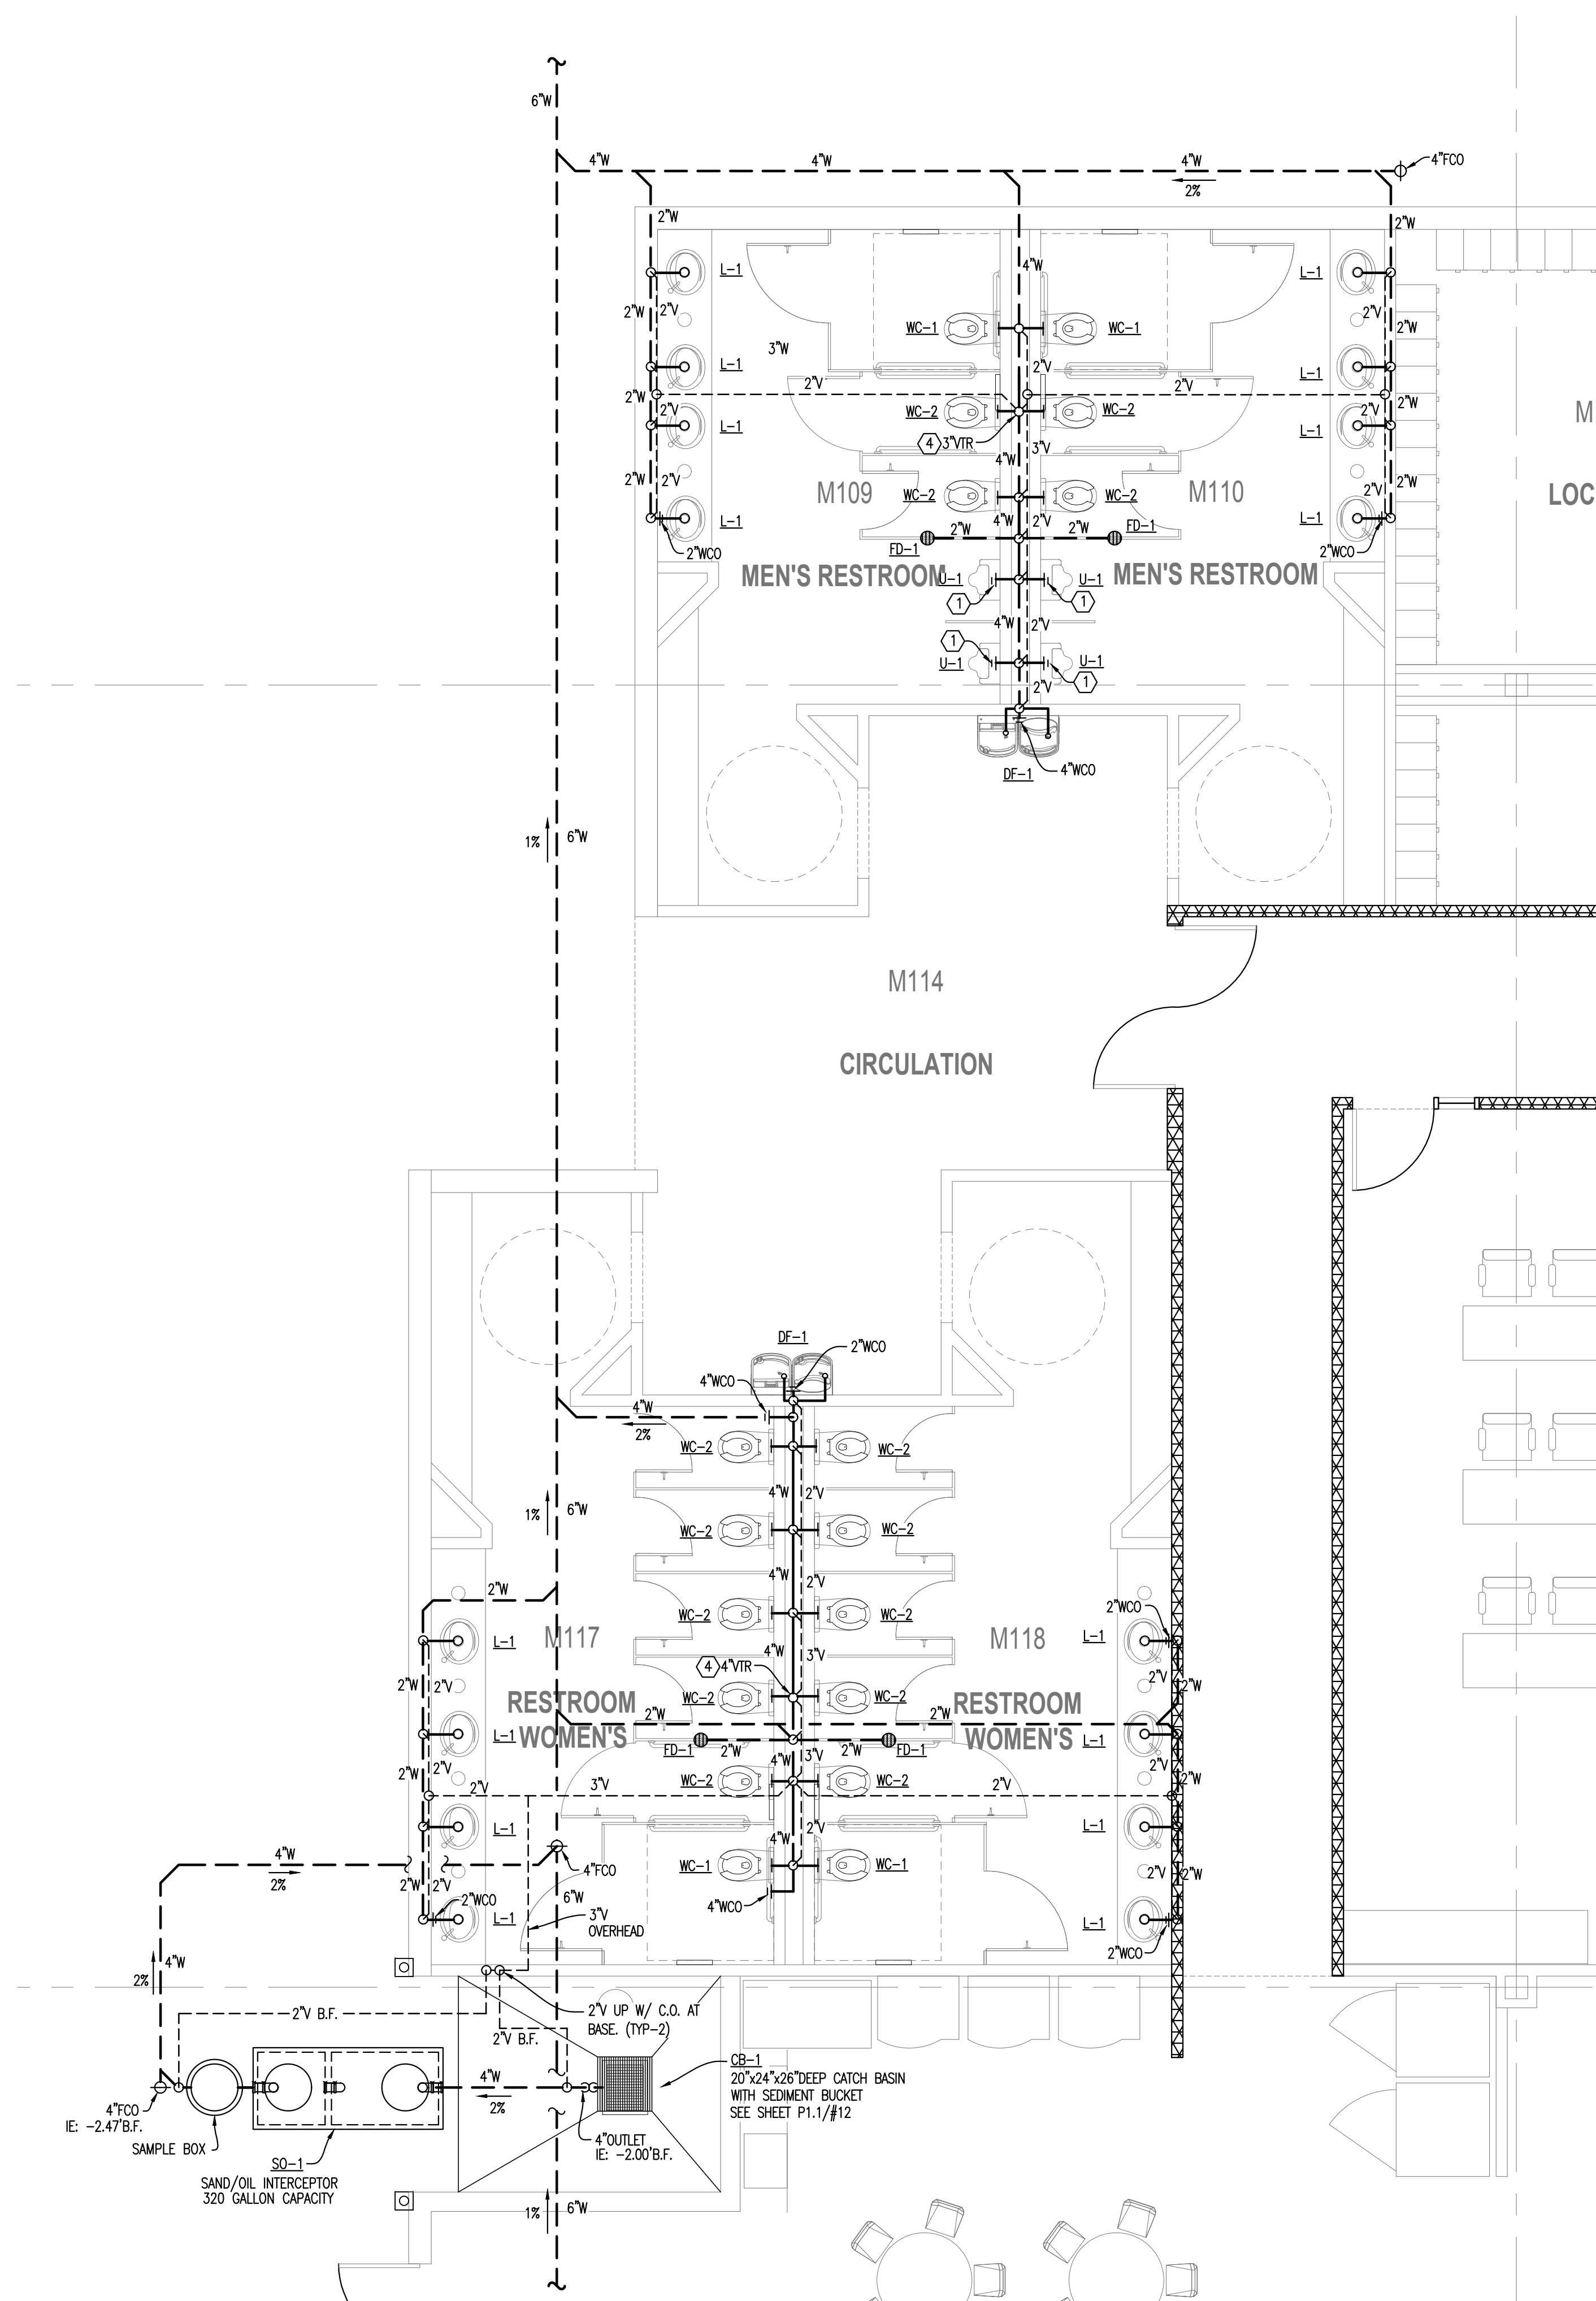

ENLARGE PLUMBING PLAN - WASTE & VENT - MAIN OFFICE

SCALE 1/4"=1'-0" 1

KEYED NOTES:

- 1 2" WALL CLEAN-OUT SHALL BE INSTALLED ABOVE THE FIXTURE CONNECTION FITTING, SERVING EACH URINAL, REGARDLESS OF THE LOCATION OF THE URINAL IN THE BUILDING. CPC 2016 707.4
- 2 CONTRACTOR SHALL MAINTAIN V.T.R. 10'-0" MIN DISTANCE AWAY FROM ALL ROOF TOP A/C UNIT'S FRESH AIR INTAKE.
- 3 PROVIDE CIRCUIT SOLVER CS-3/4-120, THERMOSTATIC BALANCING VALVE, SET TO 120°F. OR APPROVED EQUAL. PROVIDE ACCESS PANEL OVER HARD LID CEILING.
- 4 PROVIDE POINT OF USE THERMOSTATIC MIXING VALVE, (TMV-1) & SET TO 108°F MAX.
- 5 COLD WATER DN IN WALL, PROVIDE SOV AT 5'-0" A.F.F. W/ ACCESS PANEL. WATER LINE SIZE AS NOTED.
- 6 WATER HAMMER ARRESTER (WHA) W/ ACCESS PANEL.
- 7 TRAP PRIMER DEVICE, (TP-1) W/ ACCESS PANEL. EXTEND 1/2" TRAP PRIMER WATER LINE TO DRAIN TRAP.



hpa, inc.
18831 bardeen avenue, - ste. #100
irvine, ca 92612
tel: 949-863-1770
fax: 949-863-0851
email: hpa@hparchs.com

Owner:



1140 N. Coast Highway
Laguna Beach, CA 92651
tel: (949) 655-8227

Project:

1110 W. MERRILL AVE.

1110 W. Merrill Ave
Rialto, CA

Consultants:

Civil: -
Structural: MIYAMOTO
Mechanical: RPM
Plumbing: RPM
Electrical: RPM
Landscape: -
Fire Protection: -
Soils Engineer: -

ENLARGE PLUMBING PLAN -
WATER WASTE & VENT

Project Number: 18477.04
Drawn by: JW
Date: 3/9/2020
Revision:
ASJ#1 03/12/19
ASJ#3 03/09/20

Sheet:

P4.0



RPM
Engineers, Inc.
102 DISCOVERY
IRVINE, CA 92618
Tel: 949-450-1550 (317)
Fax: 949-450-1654
Contact: Jose Beltran
e-mail: joseb@rpmpe.com

RPM#20-132 03/20/20